


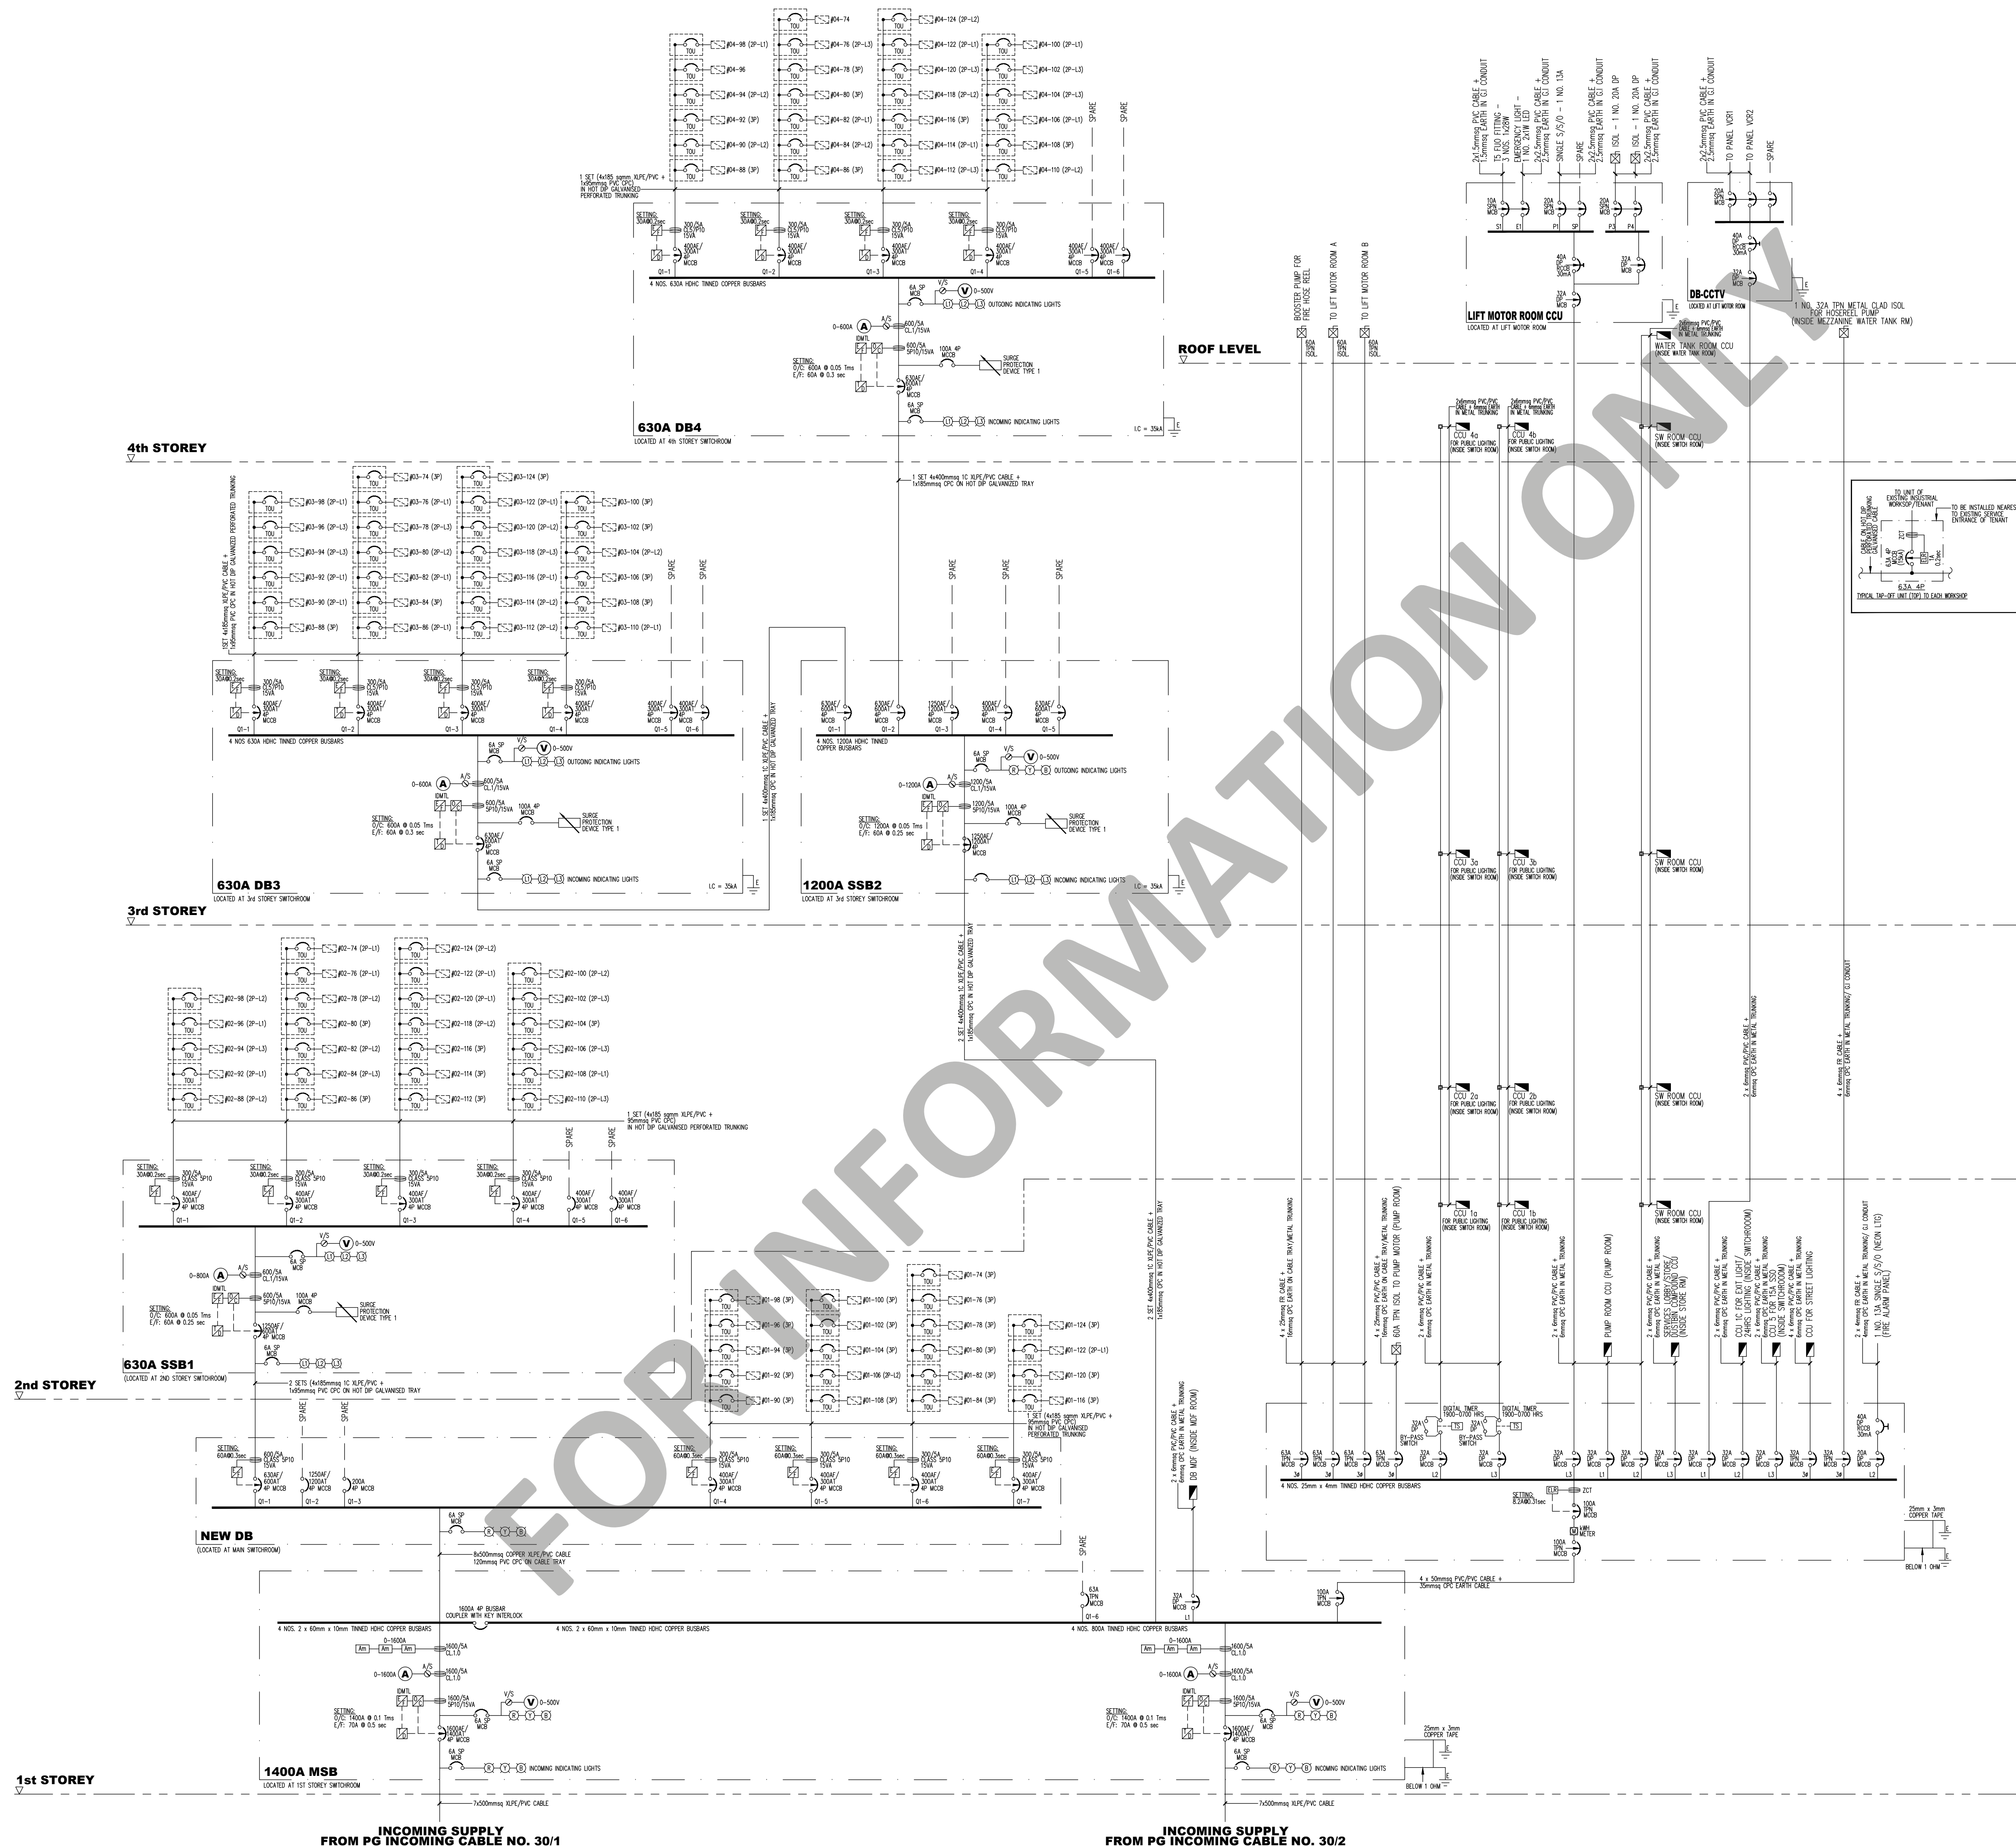

NOTES:

REV	DESCRIPTIONS	DATE	BY
0	SUBMITTED TO EMA	APR 2024	HS

OWNER:

JTC CORPORATION

8
JURONG TOWN HALL ROAD
THE JTC SUMMIT
SINGAPORE 609434

LEW:

ON **ENGINEERS** **PTE LTD**
 14 GUL AVENUE
 LEVEL 7
 SINGAPORE 629657
 TEL: 6795 4666
 FAX: 6795 4222

LEW: WAN SIEW KAY TOM
 LICENCE NO: 9/10206
 EMAIL: siewkay.wan@onengineers.com

IN CASE OF EMERGENCY CALL THE NEAREST HOSPITAL

IN CASE OF EMERGENCY
CALL: 995

FOR NON- EMERGENCY
CALL: 1777
FOR AMBULANCE ASSISTANCE

PROJECT:
ELECTRICAL INSTALLATION AT
22, 23, 24, 25, 26, 27, 28, 29, 30, 31, 32,
37 & 38 DEFU LANE 10
DEFU LANE INDUSTRIAL ESTATE,
SINGAPORE 539203 FOR
JTC CORPORATION

DRAWING TITLE:
ELECTRICAL SINGLE LINE DIAGRAM
MSB FOR BLK 30

SCALE: N.T.S.

DRAWN BY: HS

DATE: APR 2024

CHECKED BY: WSK

DRAWING NO:
ON/E139160/ESL02

REV.:
 0

SHT.:
 2 OF 8