


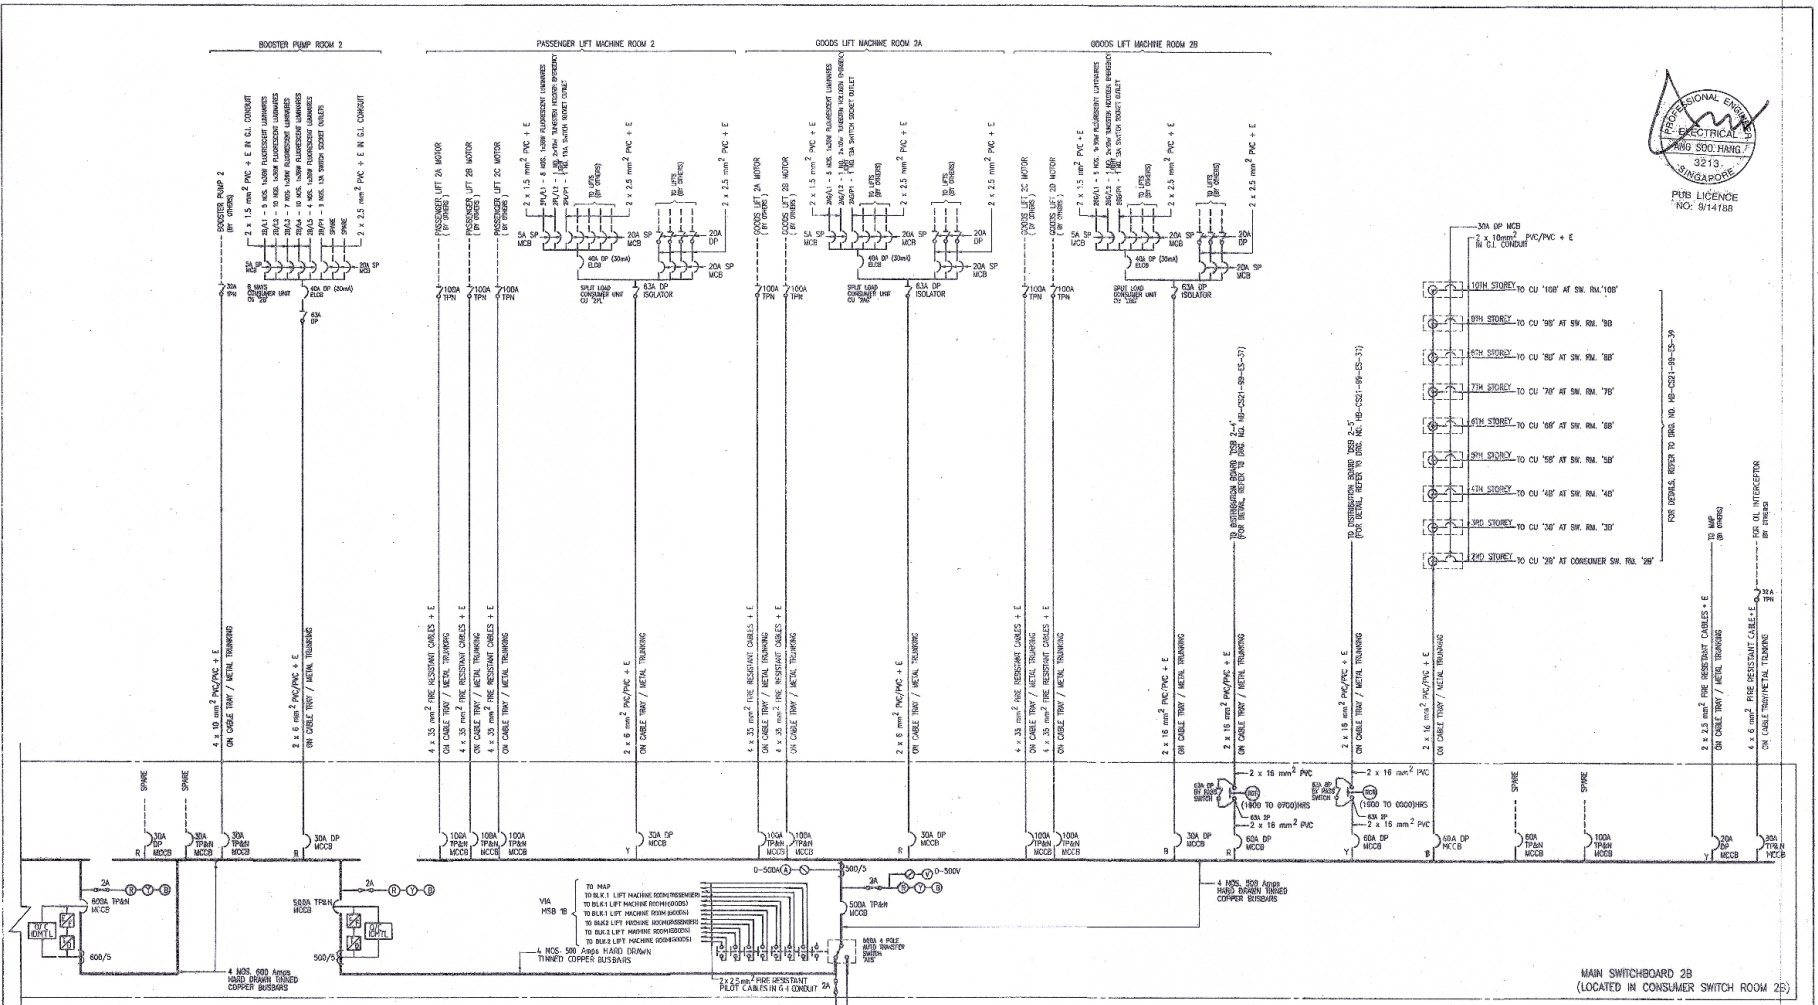

NOTES:
1) FOR ELECTRICAL GENERAL NOTES, REFER TO DRG. NO. HD-CST-99-03-2
2) TERNWOOD BOARD FOR ALL ELECTRICAL METERING TO BE PROVIDED BY ELECTRICAL CONTRACTOR
3) LOCATION OF MCB SUBJECT TO CONFORMANCE AT SITE

ELECTRICAL LEGEND		ELECTRICAL LEGEND		ELECTRICAL LEGEND	
	MCB		RPR		BUSSBAR
	FUSE		PSC		EMB
	CB		V		MDA
	I		A		TDR
	C		M		E
	KM		CT		EL

CONTRACT ELECTRICAL

JOB TITLE: PROPOSED 2-BLOCK OF 10-STORY LIGHT PLANT FACTORY ON LOTS 4439PT, 90-0PT, 92-0PT, 92-0-0 AND 92-0-0PT, BEHIND 23 AT BANG BUNT JACHIE 3 / BANG BUNT ROAD 3 (BANG BUNT IND. EST. CONT. 10)

DRAWING TITLE: (EST. BLDG. NO. 2) SINGLE LINE DIAGRAM (PART 2) (MAIN SWITCHBOARD 2B)

DRAWING NO. HD-CST-99-03-350

SCALE: N.T.S.

DATE: JAN 1999

DESIGNER: YEO KIN HUAT

CHECKED: YEO KIN HUAT

APPROVED: YEO KIN HUAT

WITNESSED: YEO KIN HUAT

DATE: _____